


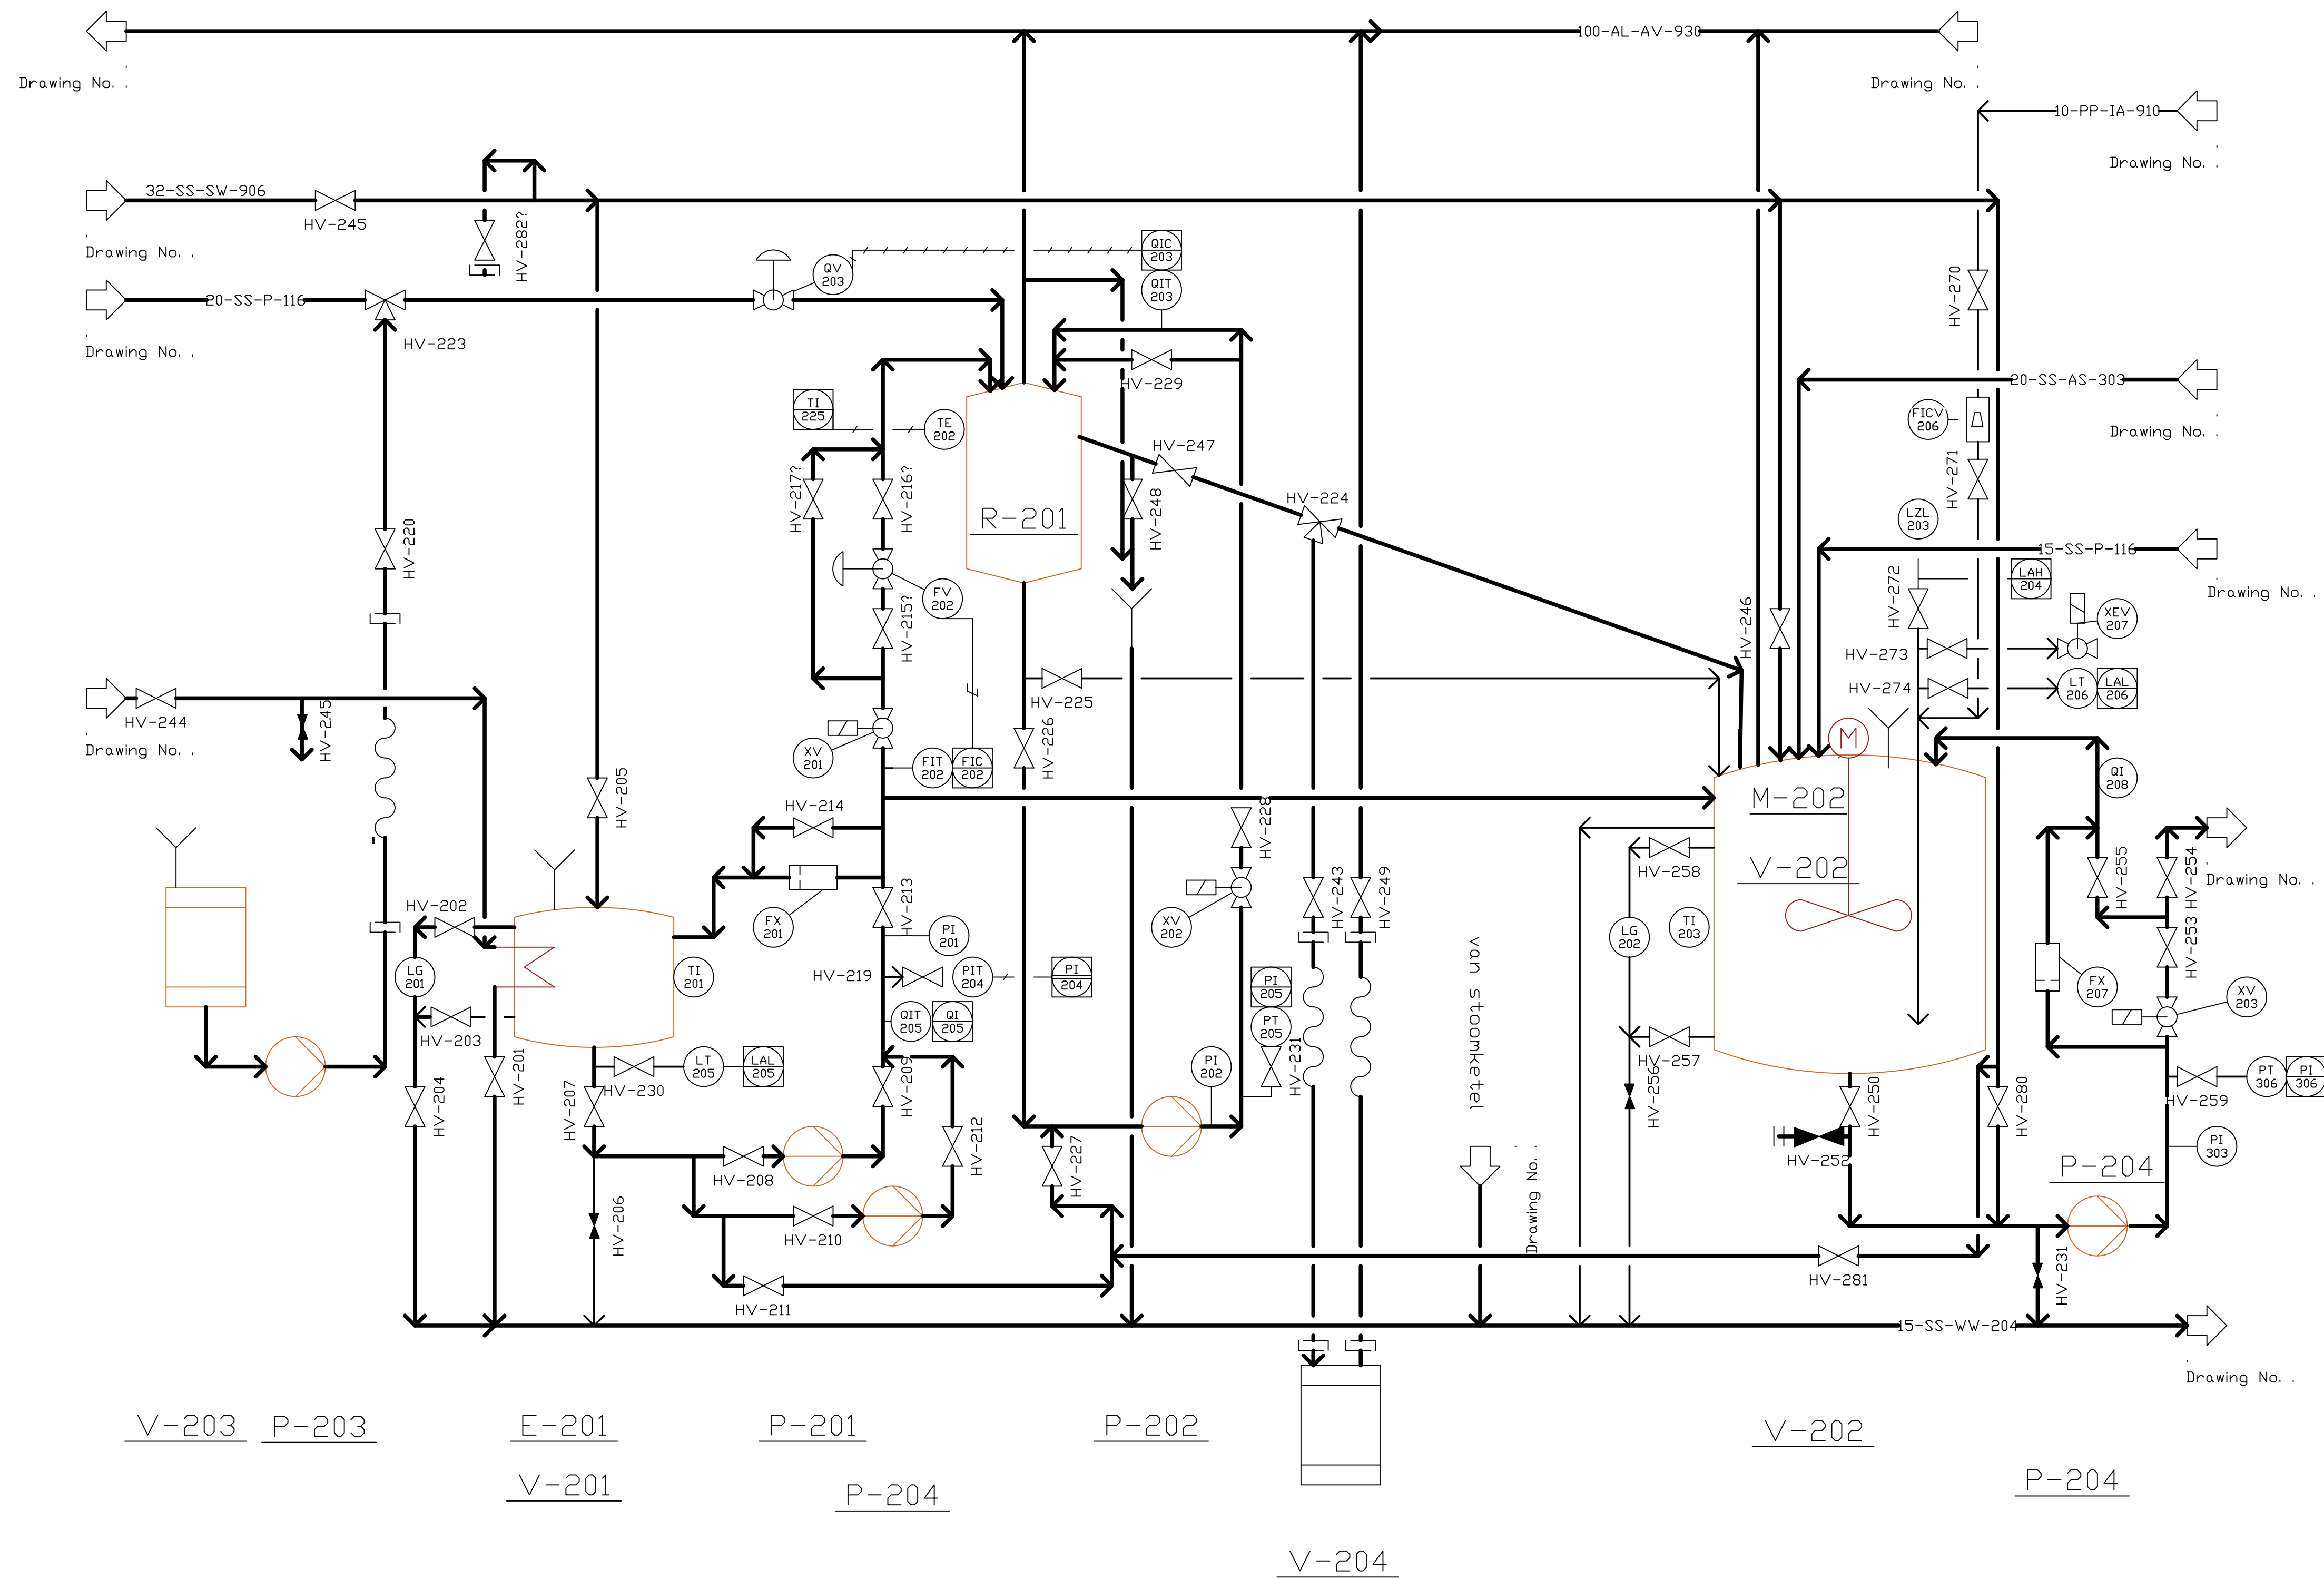

General Notes

3	As built	02/11/2023
2	As built	20/2/2023
1	As built	21/4/2022
No.	Revision/Issue	Date

Drawing Name

P&ID
Unit 2
Reactor
batch proces

Project Name and Address

Proeffabriek
Vista college
Arendstraat 12
Sittard

Area Proces	Stamp
Drawing Number PB201	
Author b.selbeck	